


SERVICE PIPE

METER STAND


COMMUNICATION PIPE

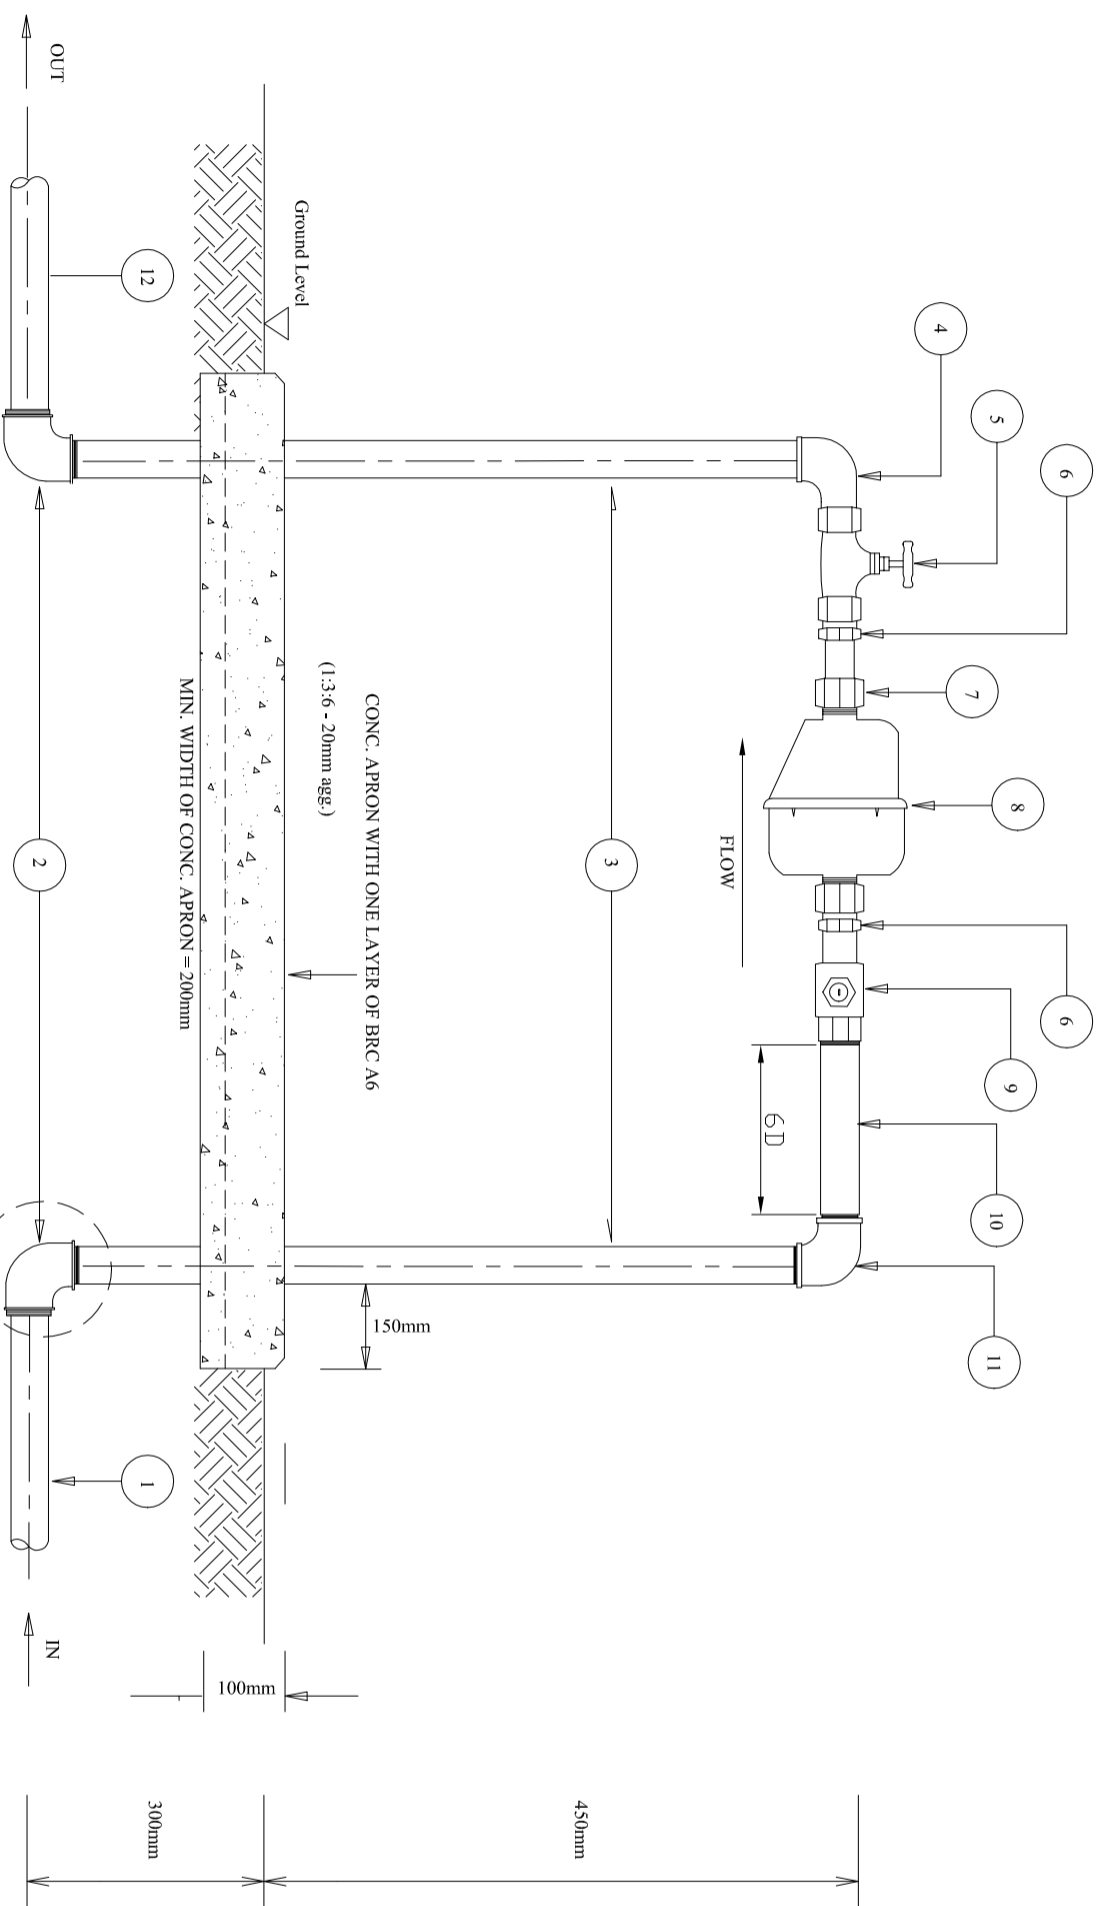

FRONT ELEVATION


DETAIL 'A'

METER SIZE (mm) D	METER STAND PIPE SIZE (mm)	6D (mm)
15	20	90 (mm)

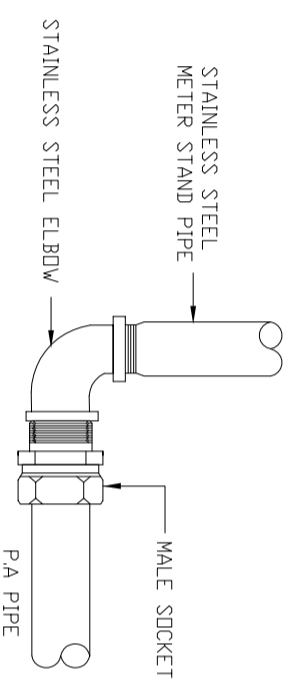

DETAIL 'A'

POLY ALUMINIUM COMMUNICATION PIPE

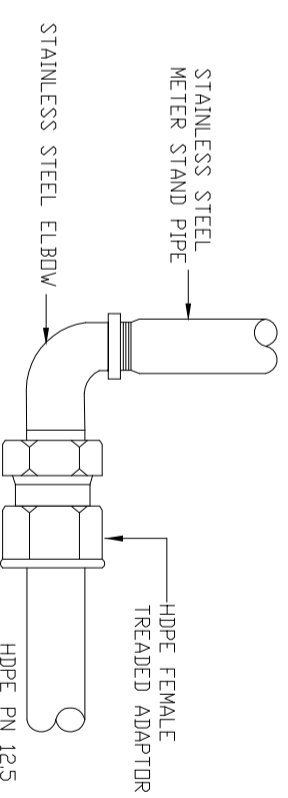

DETAIL 'A'

HDPE PN 12.5 COMMUNICATION PIPE

NOTE :

- SPECIFICATIONS
1. ALL STAINLESS STEEL PIPES SHALL BE OF ADEQUATE COMPLYING WITH
  2. ALL FITTINGS SHALL BE OF STAINLESS STEEL CONFORMING TO SAMA 531 OR BRASS TIBER ADDED FITTINGS CONFORMING TO BS 128.
  3. BRASS LOCKABLE BALL VALVES (FULL BORE) TYPE SHALL COMPLY WITH
  4. BRASS GATE VALVES SHALL CONFORM TO BS 5154 AND SHALL BE OF THE FULL BORE TYPE.

DETAILS NOTE:

1. COMMUNICATION PIPE POLY ALUMINIUM
2. STAINLESS STEEL ELBOW (INTERNALLY TREADED)
3. 20mm STAINLESS STEEL PIPE
4. STAINLESS STEEL STRAIGHT REDUCER ELBOW (MALE AND FEMALE TREAD)
5. BRASS STOP COCK
6. BRASS STAINLESS STEEL BRUSH
7. BRASS UNION/COUPLING
8. WATER METER
9. BRASS LOCKABLE VALVE (SWIVEL NUTS) TO BE INSTALLED WITH LOCK TACKING THE ROAD
10. 20mm STAINLESS STEEL SHORTPIECE
11. STAINLESS STEEL ELBOW (INTERNALLY TREADED)
12. SERVICE PIPE

REV.	REVISD BY	DESCRIPTION	DATE



**SAU Holdings Sdn Bhd.** (476718-H)  
 Jalan Garuda, Landin, P.O Box 262,  
 80350 Johor Bahru, Johor, Malaysia  
 T. +607 - 224 4040 F. +607 - 224 0033

1800-86-7474 sm 019-772 7474 www.sau.com.my customer.care@sau.com.my

PROJECT :

DRAWING TITLE :

TYPICAL DOMESTIC SINGLE METER INSTALLATION WITH INLINE LOCKABLE VALVE (SWIVEL NUTS) (Meter Size 15mm)

DRAWN BY : MYR	DESIGNED : W/C
CHECKED : MFB	APPROVED : T/C
SCALE : NOT TO SCALE	DATE : DECEMBER 2013
DRAWING NO. : SAJSTD/MP/01	